



8303 Waterbury Drive  
Houston, TX 77055  
P 713.701.9154

gene@paradigmhouston.com

THIS PLAN AND THE DESIGNS CONTAINED HEREIN ARE THE PROPERTY OF PARADIGM DESIGN INNOVATIONS. DESIGNER. THIS DRAWING SET AND ALL OF ITS CONTENTS ARE SUBJECT TO COPYRIGHT AND MAY NOT BE REPRODUCED, TRANSMITTED OR REPRODUCED ALL OR IN PART, WITHOUT PRIOR WRITTEN CONSENT FROM THE DESIGNER OR HIS ASSIGNS.

THE GENERAL CONTRACTOR IS RESPONSIBLE FOR CONFIRMING AND CORRELATING DIMENSIONS AT THE JOB SITE. THE DESIGNER WILL NOT BE RESPONSIBLE FOR CONSTRUCTION MEANS, METHODS, TECHNIQUES, SEQUENCES OR PROCEDURES, OR FOR SAFETY PRECAUTIONS AND PROGRAMS, IN CONNECTION WITH THE PROJECT.

**Owner/Developer**

K. Duncan

**Contractor**

Frederico Matamoros

**Structural Engineer**

TBD

**PAVONES POINT**  
Pavones Point  
Costa Rica

Job Number: 218017  
Client: K. Duncan

Drawings Issued For

**CONCEPTUAL DESIGN**

**Document Information**

CAD FILE NAME: 20180314-Pavones Point.pln

DESIGNED BY: Gene Johnston  
DRAWN BY: Gene Johnston  
CHECKED BY: Gene Johnston  
COPYRIGHT: Paradigm Design - 2018


**Project History**

Date:	Issue:
03.27.18	Client Review (SD)
03.00.00	City Submittal (Permit)
00.00.00	City Comments (CD)
00.00.00	Client Review (CD)


27 MARCH 2018

**FIRST LEVEL 2 - 1 - 2  
OPTION B**

**A1.1**

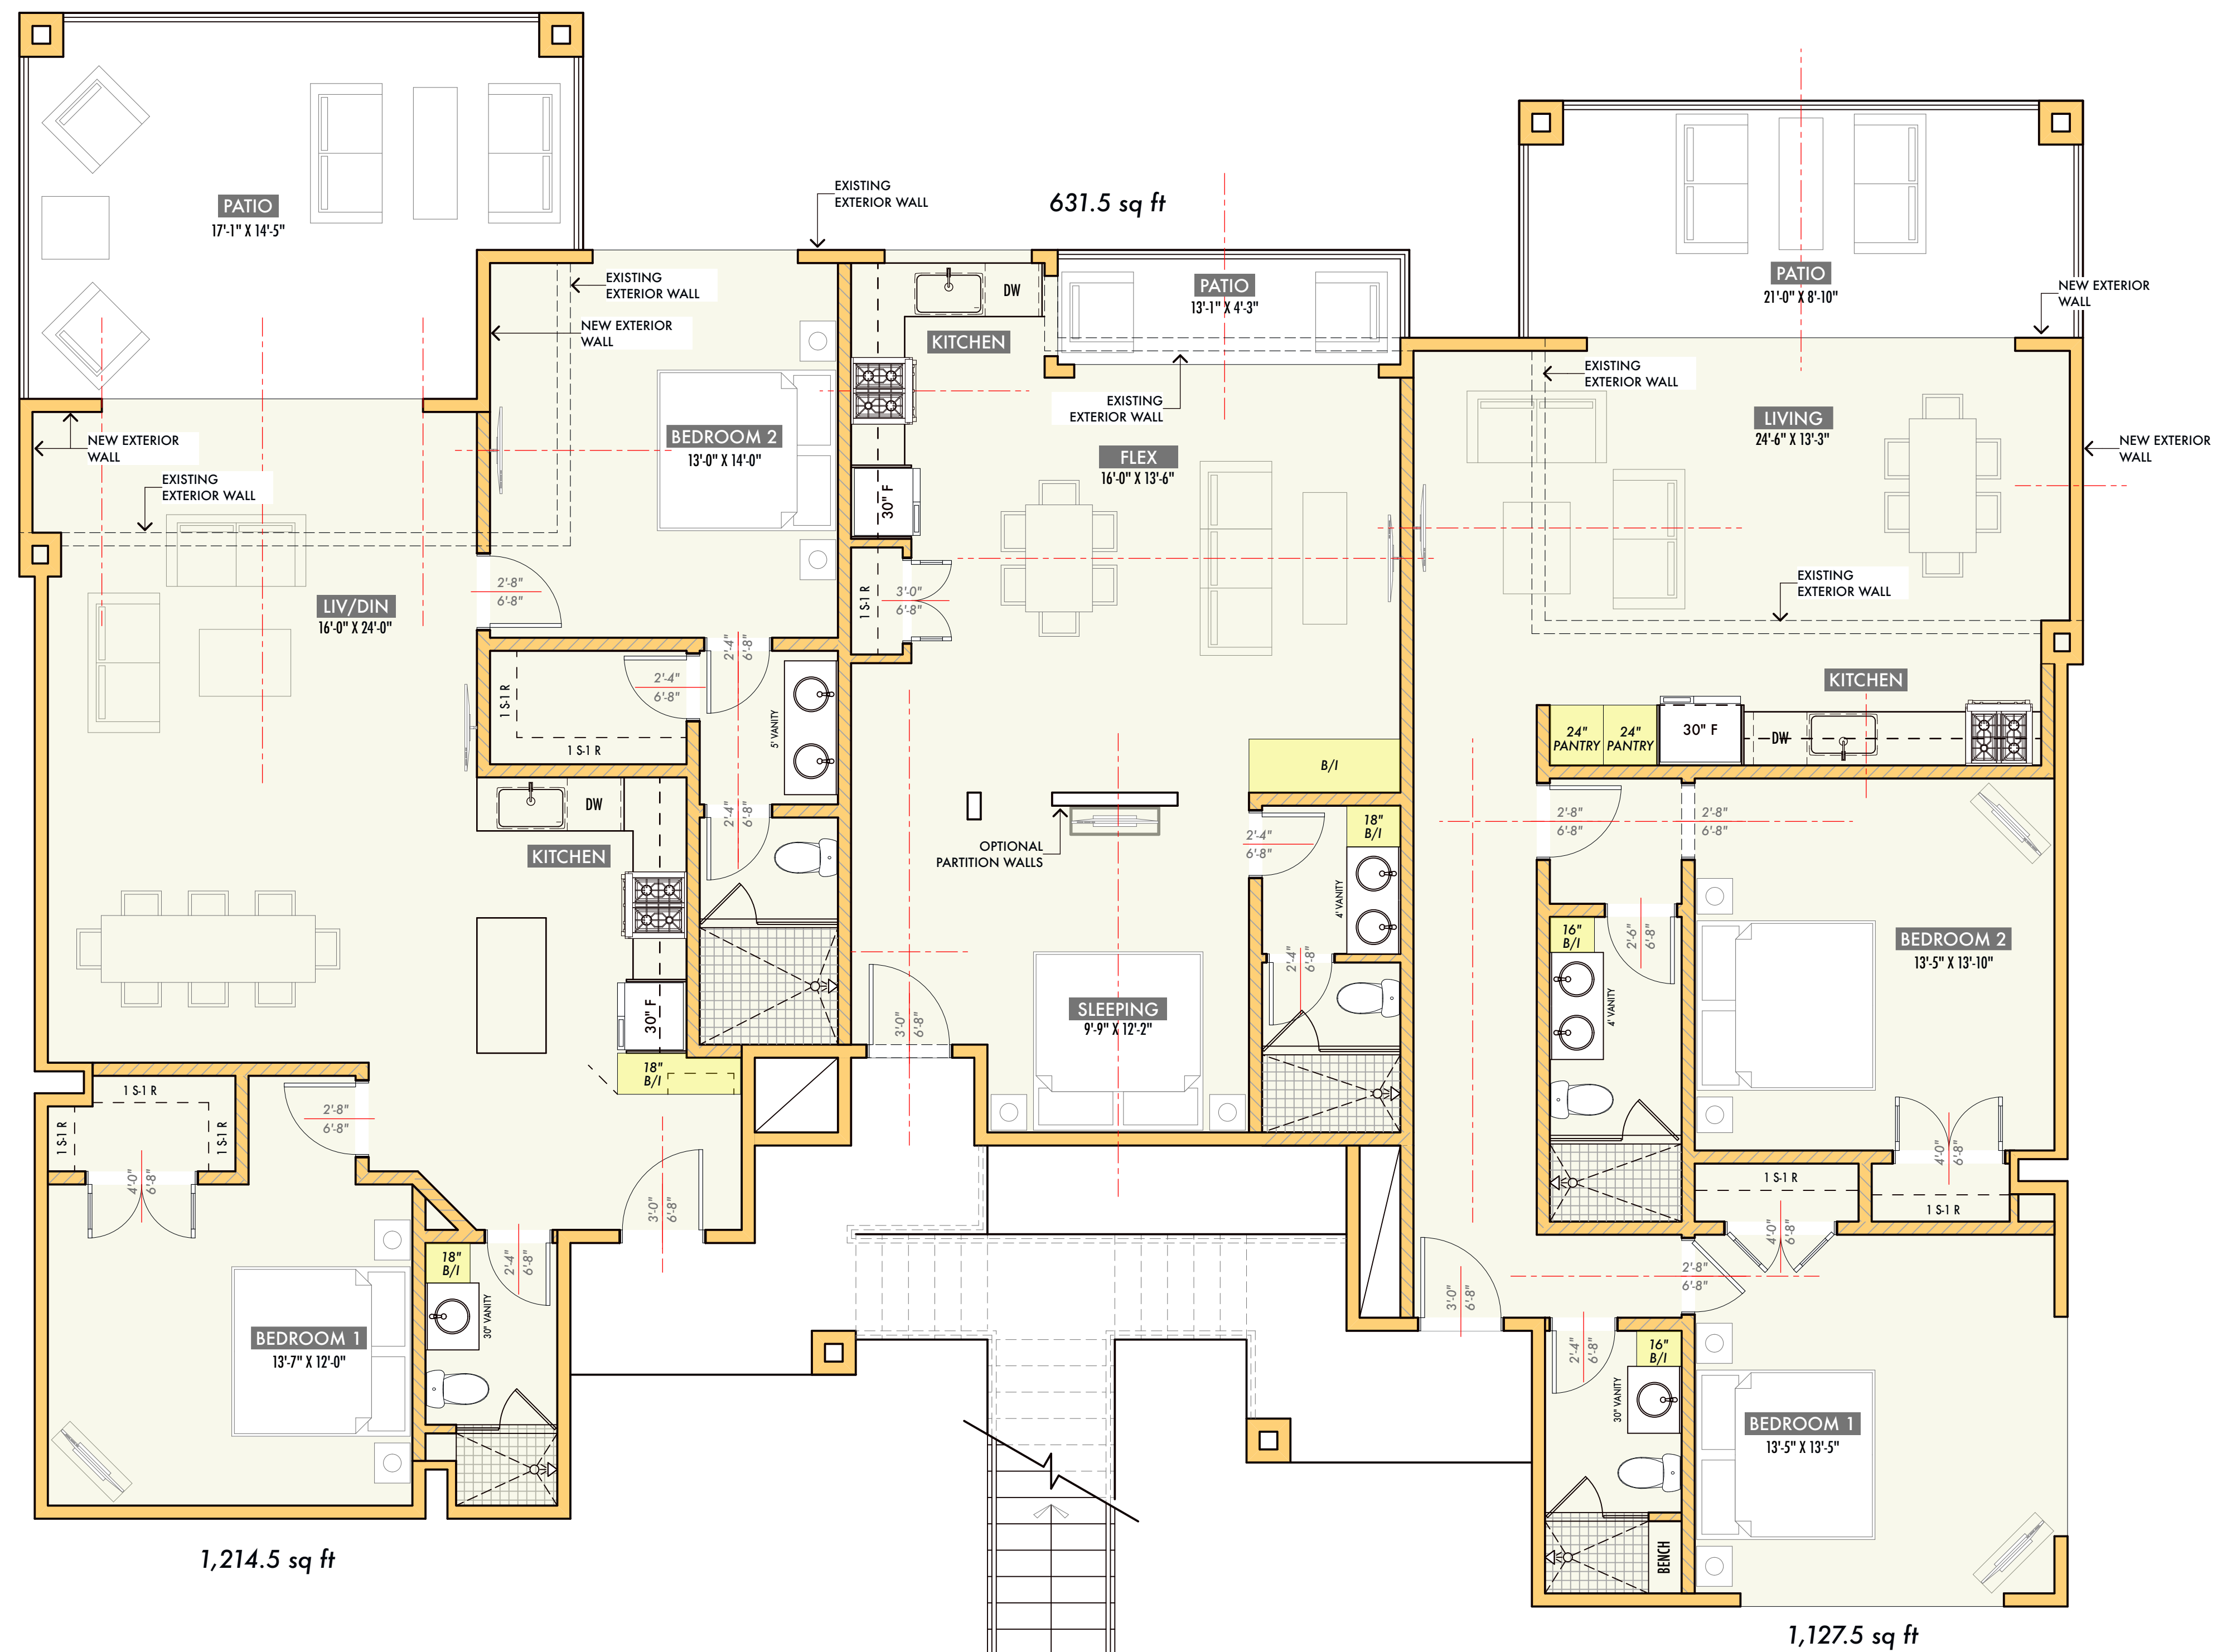

 **12**  
**A1.1** **First Level Plan 2 - 1 - 2 / Option B**  
SCALE: 1/4" = 1'-0"



**NOTE:**  
- ALL DOORS AND WINDOWS HAVE NOT BEEN PLACED  
- WOULD LIKE OPTION TO USE A NEW DOOR AND WINDOW PACKAGE VS EXISTING PACKAGE ON EXISTING BUILDINGS



8303 Waterbury Drive  
Houston, TX 77055  
P 713.701.9154

gene@paradigmhouston.com

THIS PLAN AND THE DESIGNS CONTAINED HEREIN ARE THE PROPERTY OF PARADIGM DESIGN INNOVATIONS. DESIGNER: THIS DRAWING SET AND ALL OF ITS CONTENTS ARE SUBJECT TO COPYRIGHT AND MAY NOT BE REPRODUCED, TRANSFERRED OR REPRODUCED ALL OR IN PART, WITHOUT PRIOR WRITTEN CONSENT FROM THE DESIGNER OR HIS ASSIGNS.

THE GENERAL CONTRACTOR IS RESPONSIBLE FOR CONFIRMING AND CORRELATING DIMENSIONS AT THE JOB SITE. THE DESIGNER WILL NOT BE RESPONSIBLE FOR CONSTRUCTION MEANS, METHODS, TECHNIQUES, SEQUENCES OR PROCEDURES, OR FOR SAFETY PRECAUTIONS AND PROGRAMS, IN CONNECTION WITH THE PROJECT.

**Owner/Developer**

K. Duncan

**Contractor**

Frederico Matamoros

**Structural Engineer**

TBD

PAVONES POINT

Pavones Point  
Costa Rica

Job Number: 218017  
Client: K. Duncan

Drawings Issued For

**CONCEPTUAL DESIGN**

**Document Information**

CAD FILE NAME: 20180314-Pavones Point.pln

DESIGNED BY: Gene Johnston  
DRAWN BY: Gene Johnston  
CHECKED BY: Gene Johnston  
COPYRIGHT: Paradigm Design - 2018

**Project History**

Date:	Issue:
03.27.18	Client Review (SD)
03.00.00	City Submittal (Permit)
00.00.00	City Comments (CD)
00.00.00	Client Review (CD)

 
27 MARCH 2018

**FIRST LEVEL 3 - 1 - 2  
OPTION D**

A1.2



16 First Level Electrical Plan  
A1.2 SCALE: 1/4" = 1'-0"



**NOTE:**  
- ALL DOORS AND WINDOWS HAVE NOT BEEN PLACED  
- WOULD LIKE OPTION TO USE A NEW DOOR AND WINDOW PACKAGE VS EXISTING PACKAGE ON EXISTING BUILDINGS